


1
Floor Plan
1/4" = 1'-0"

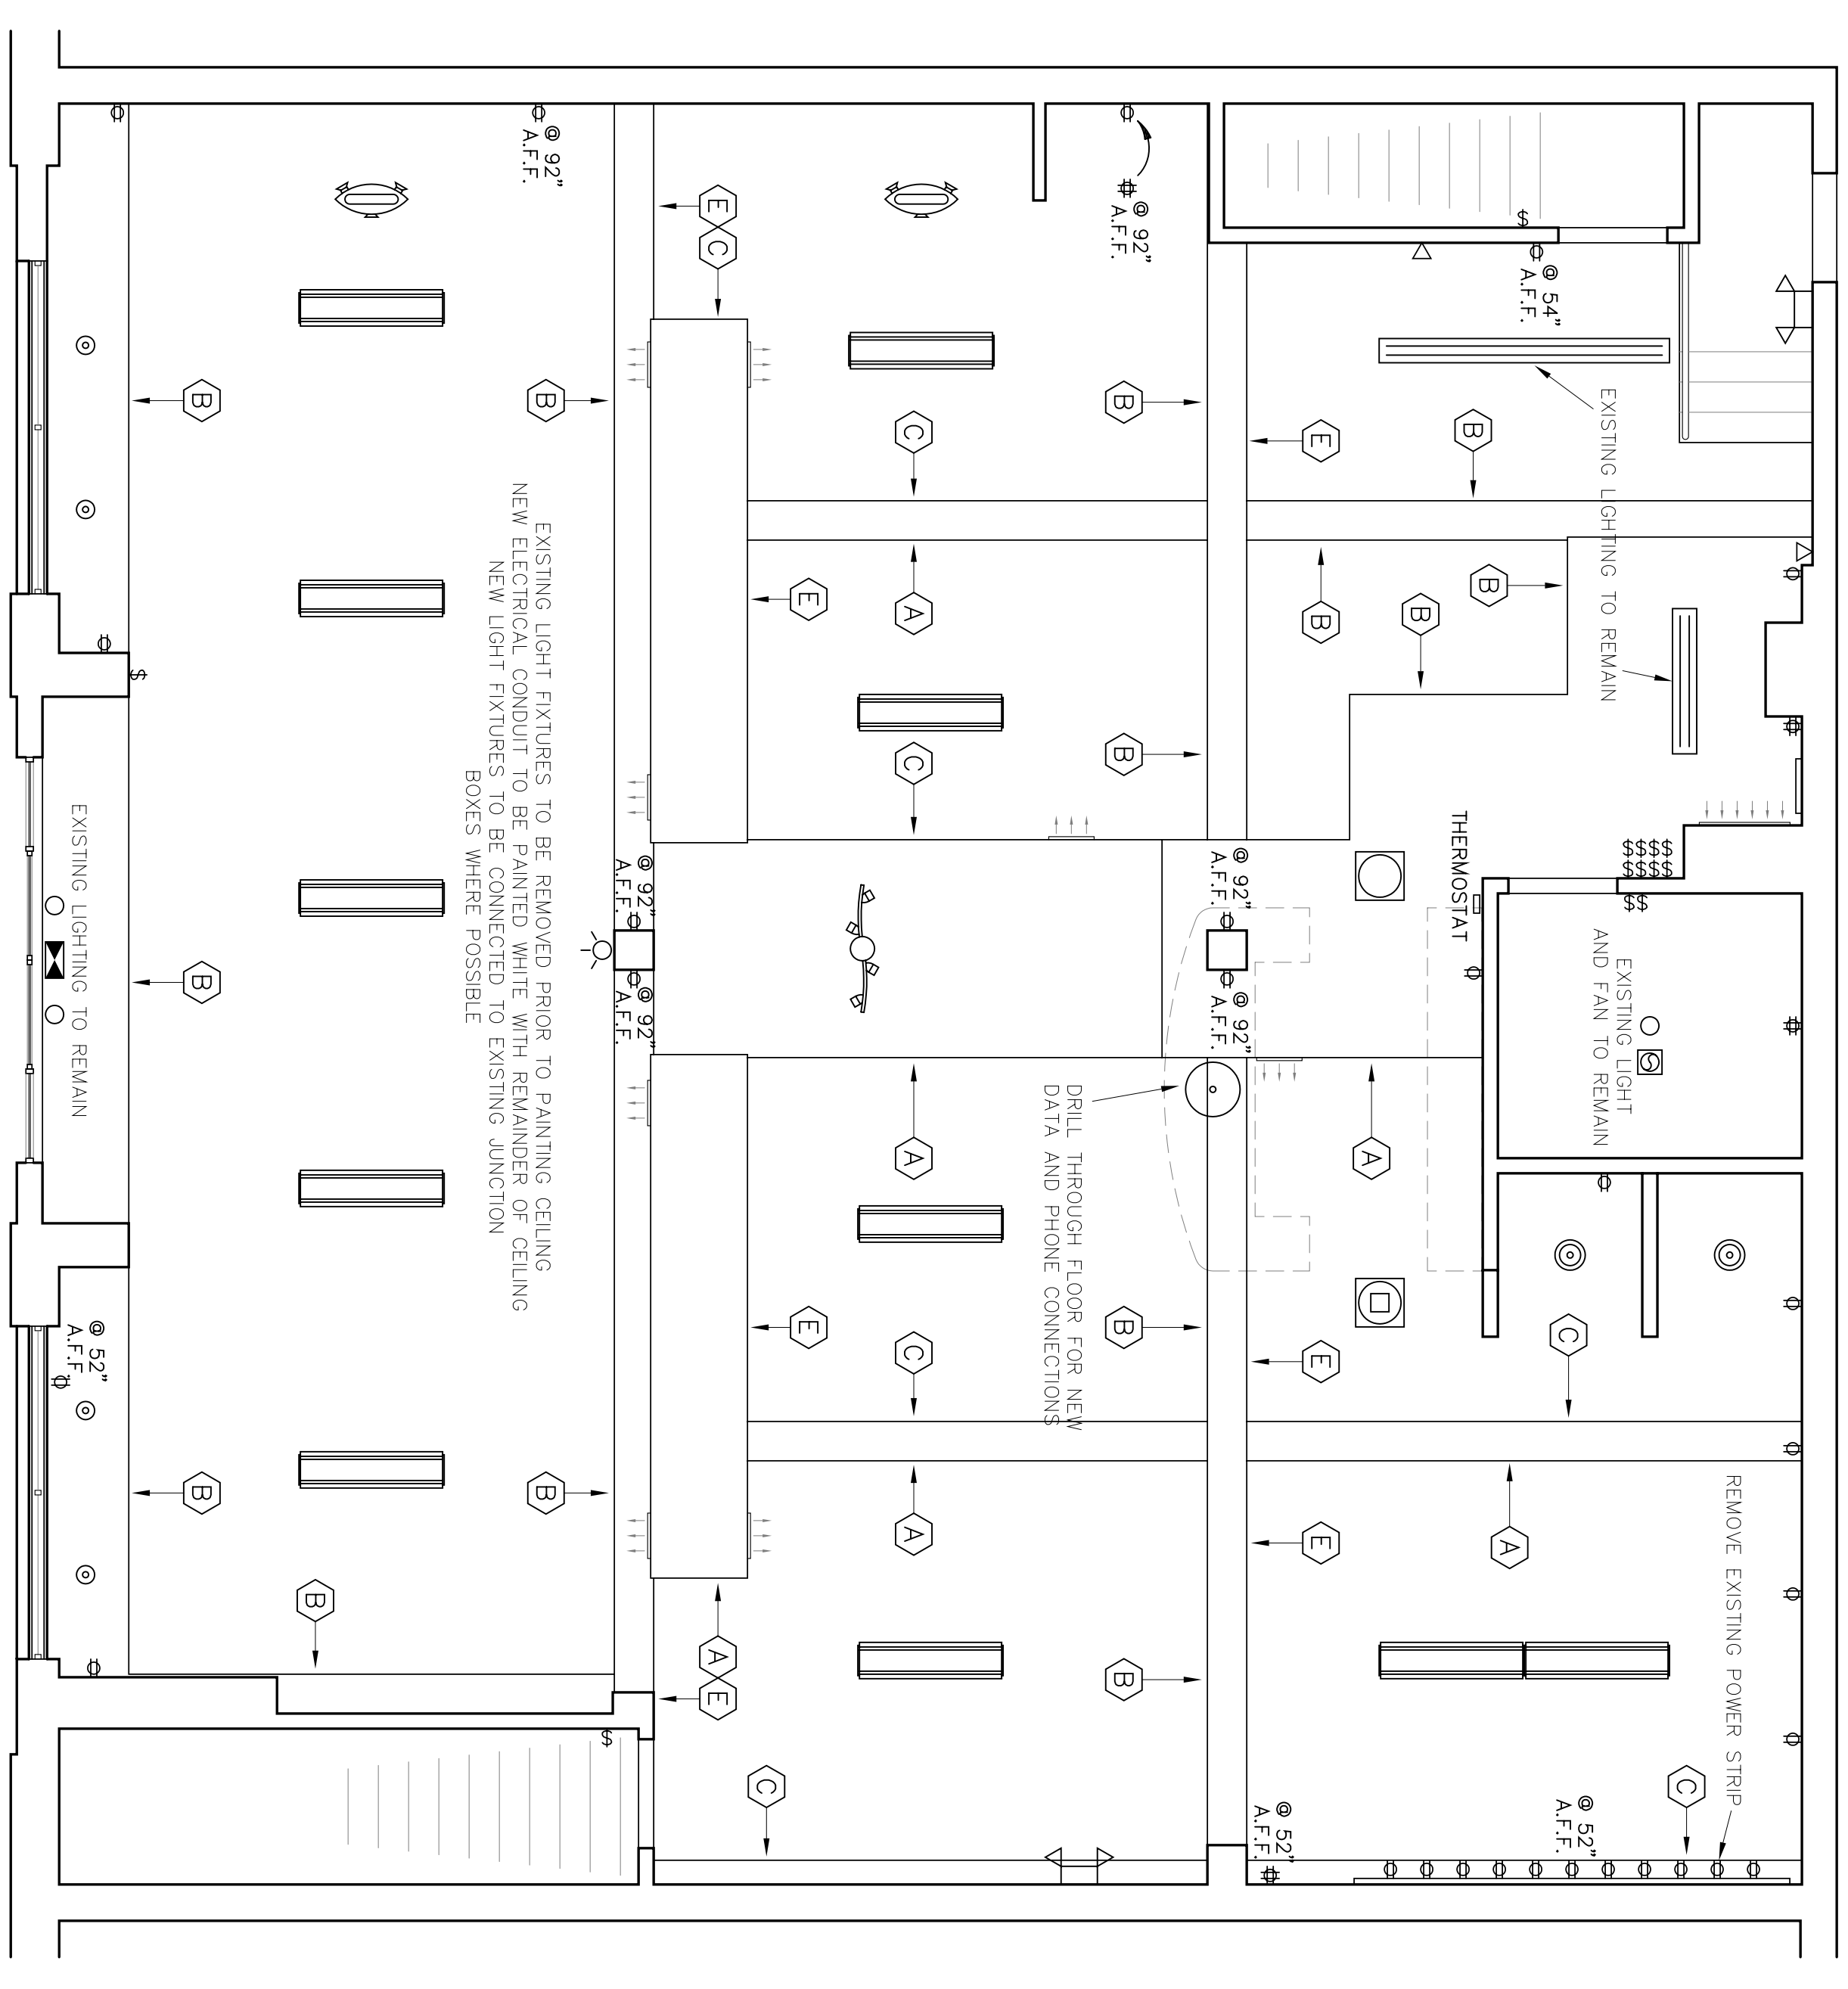

2
Reflected Ceiling Plan
1/4" = 1'-0"

FINISH SPECIFICATIONS

A	SW6064	Sherwin Williams Runbo
B	SW6064	Sherwin Williams Dignity Blue
C	SW6314	Sherwin Williams Luxurious Red
D	SW6247	Sherwin Williams Krypton
E	SW0010	Sherwin Williams Wickerwork
F	1	14" Cove base - Black
G	1	Existing ceiling to remain, ptd. white by landlord

LIGHTING SPECIFICATIONS

⊙	CBR8931-2	Hampton Bay Pendant w/Glass
⊙	PS094-13	Progress Lighting Steel Pendant
⊙	YF011	Hampton Bay 13" Flush Mount
⊙	YF013	Hampton Bay 18" Pendant
⊙	M3L1-2N	EasyLite Ultra 3 Light
⊙	PR163-02W/E	Progress Lighting 4 Light Sconce
⊙	YF009	Hampton Bay 4' 2-Lite Linear

Chisallo Running
606 North & South Rd
University City, MD

GRAY
ARCHITECT

Drawn by: NN/Craj
Date: 6-22-07

SHEET NUMBER: 01

www.grayarchitects.com 7 SWEVICER CT. OFFICE/MD 63366 (410) 363-6685